

POLE MOUNTING DETAILS

4

NO SCALE

E-105

1. ROUTE HOMERUN THROUGH LIGHTING CONTRACTOR. REFER TO DETAIL 11/E-400.
2. STUB UP LOCATION FOR (3) 3/4" CONDUITS & PULL STRINGS, TO ENTER BUILDING & UP TO 6" ABOVE CEILING. REFER TO SHEET E-401.
3. STUB-UP LOCATION FOR MENU BOARD. SIGN DISCONNECT PROVIDED BY SIGN CONTRACTOR. COORDINATE PRECISE LOCATION WITH ARCHITECT / OWNER.
4. DRIVE-THRU SENSOR LOOP. COORDINATE LOCATION. REFER TO A-405.
5. STUB-UP FOR DRIVE-THRU ORDER CONFIRMATION MONITOR. COORDINATE LOCATION WITH ARCHITECT / OWNER.
6. PROVIDE 3/4" CONDUIT FOR OPTIONAL SPEAKER WITH PULL STRING.
7. STUB-UP LOCATION FOR PYLON SIGN OR MONUMENT SIGN. ELECTRICAL CONTRACTOR TO PROVIDE DISCONNECT AT BASE OF SIGN. COORDINATE EXACT LOCATION WITH ARCHITECT/OWNER. CONNECT TO EXTERIOR BUILDING SIGN TIMER CONTROL.

SITE PLAN KEYED NOTES

3


E-105

SITE PLAN GENERAL NOTES

2

E-105

1. COORDINATE SERVICE ENTRANCE SECTION, TRANSFORMER, PRIMARY SERVICE, SECONDARY SERVICE, AND SWITCHING CABINET OR POWER POLE LOCATIONS WITH SERVING UTILITY COMPANY AND COMPLY AS REQUIRED.
2. CONTRACTOR TO BE RESPONSIBLE FOR COORDINATING AND PROVIDING REQUIRED WORK FOR SUPPLYING ELECTRICAL POWER AND TELEPHONE UTILITIES TO THE BUILDING.
3. CONTRACTOR TO PROVIDE ALL TRENCHING, BACKFILL, CONDUIT, PAD, ETC. PER THE SERVING UTILITY COMPANY SHOP DRAWINGS AND SPECIFICATIONS.
4. MINIMUM CIRCUITRY THIS SHEET TO BE #8, 3/4" CONDUIT.
5. ALL CIRCUITS SHALL INCLUDE A GROUND WIRE.
6. ESTIMATED POINT-TO-POINT TELEPHONE CONDUIT LENGTH = 175 FEET, THE CONTRACTOR SHALL USE THIS ESTIMATED CONDUIT LENGTH AS THE MINIMUM INSTALLATION TO BE INCLUDED IN THE CONSTRUCTION BID.

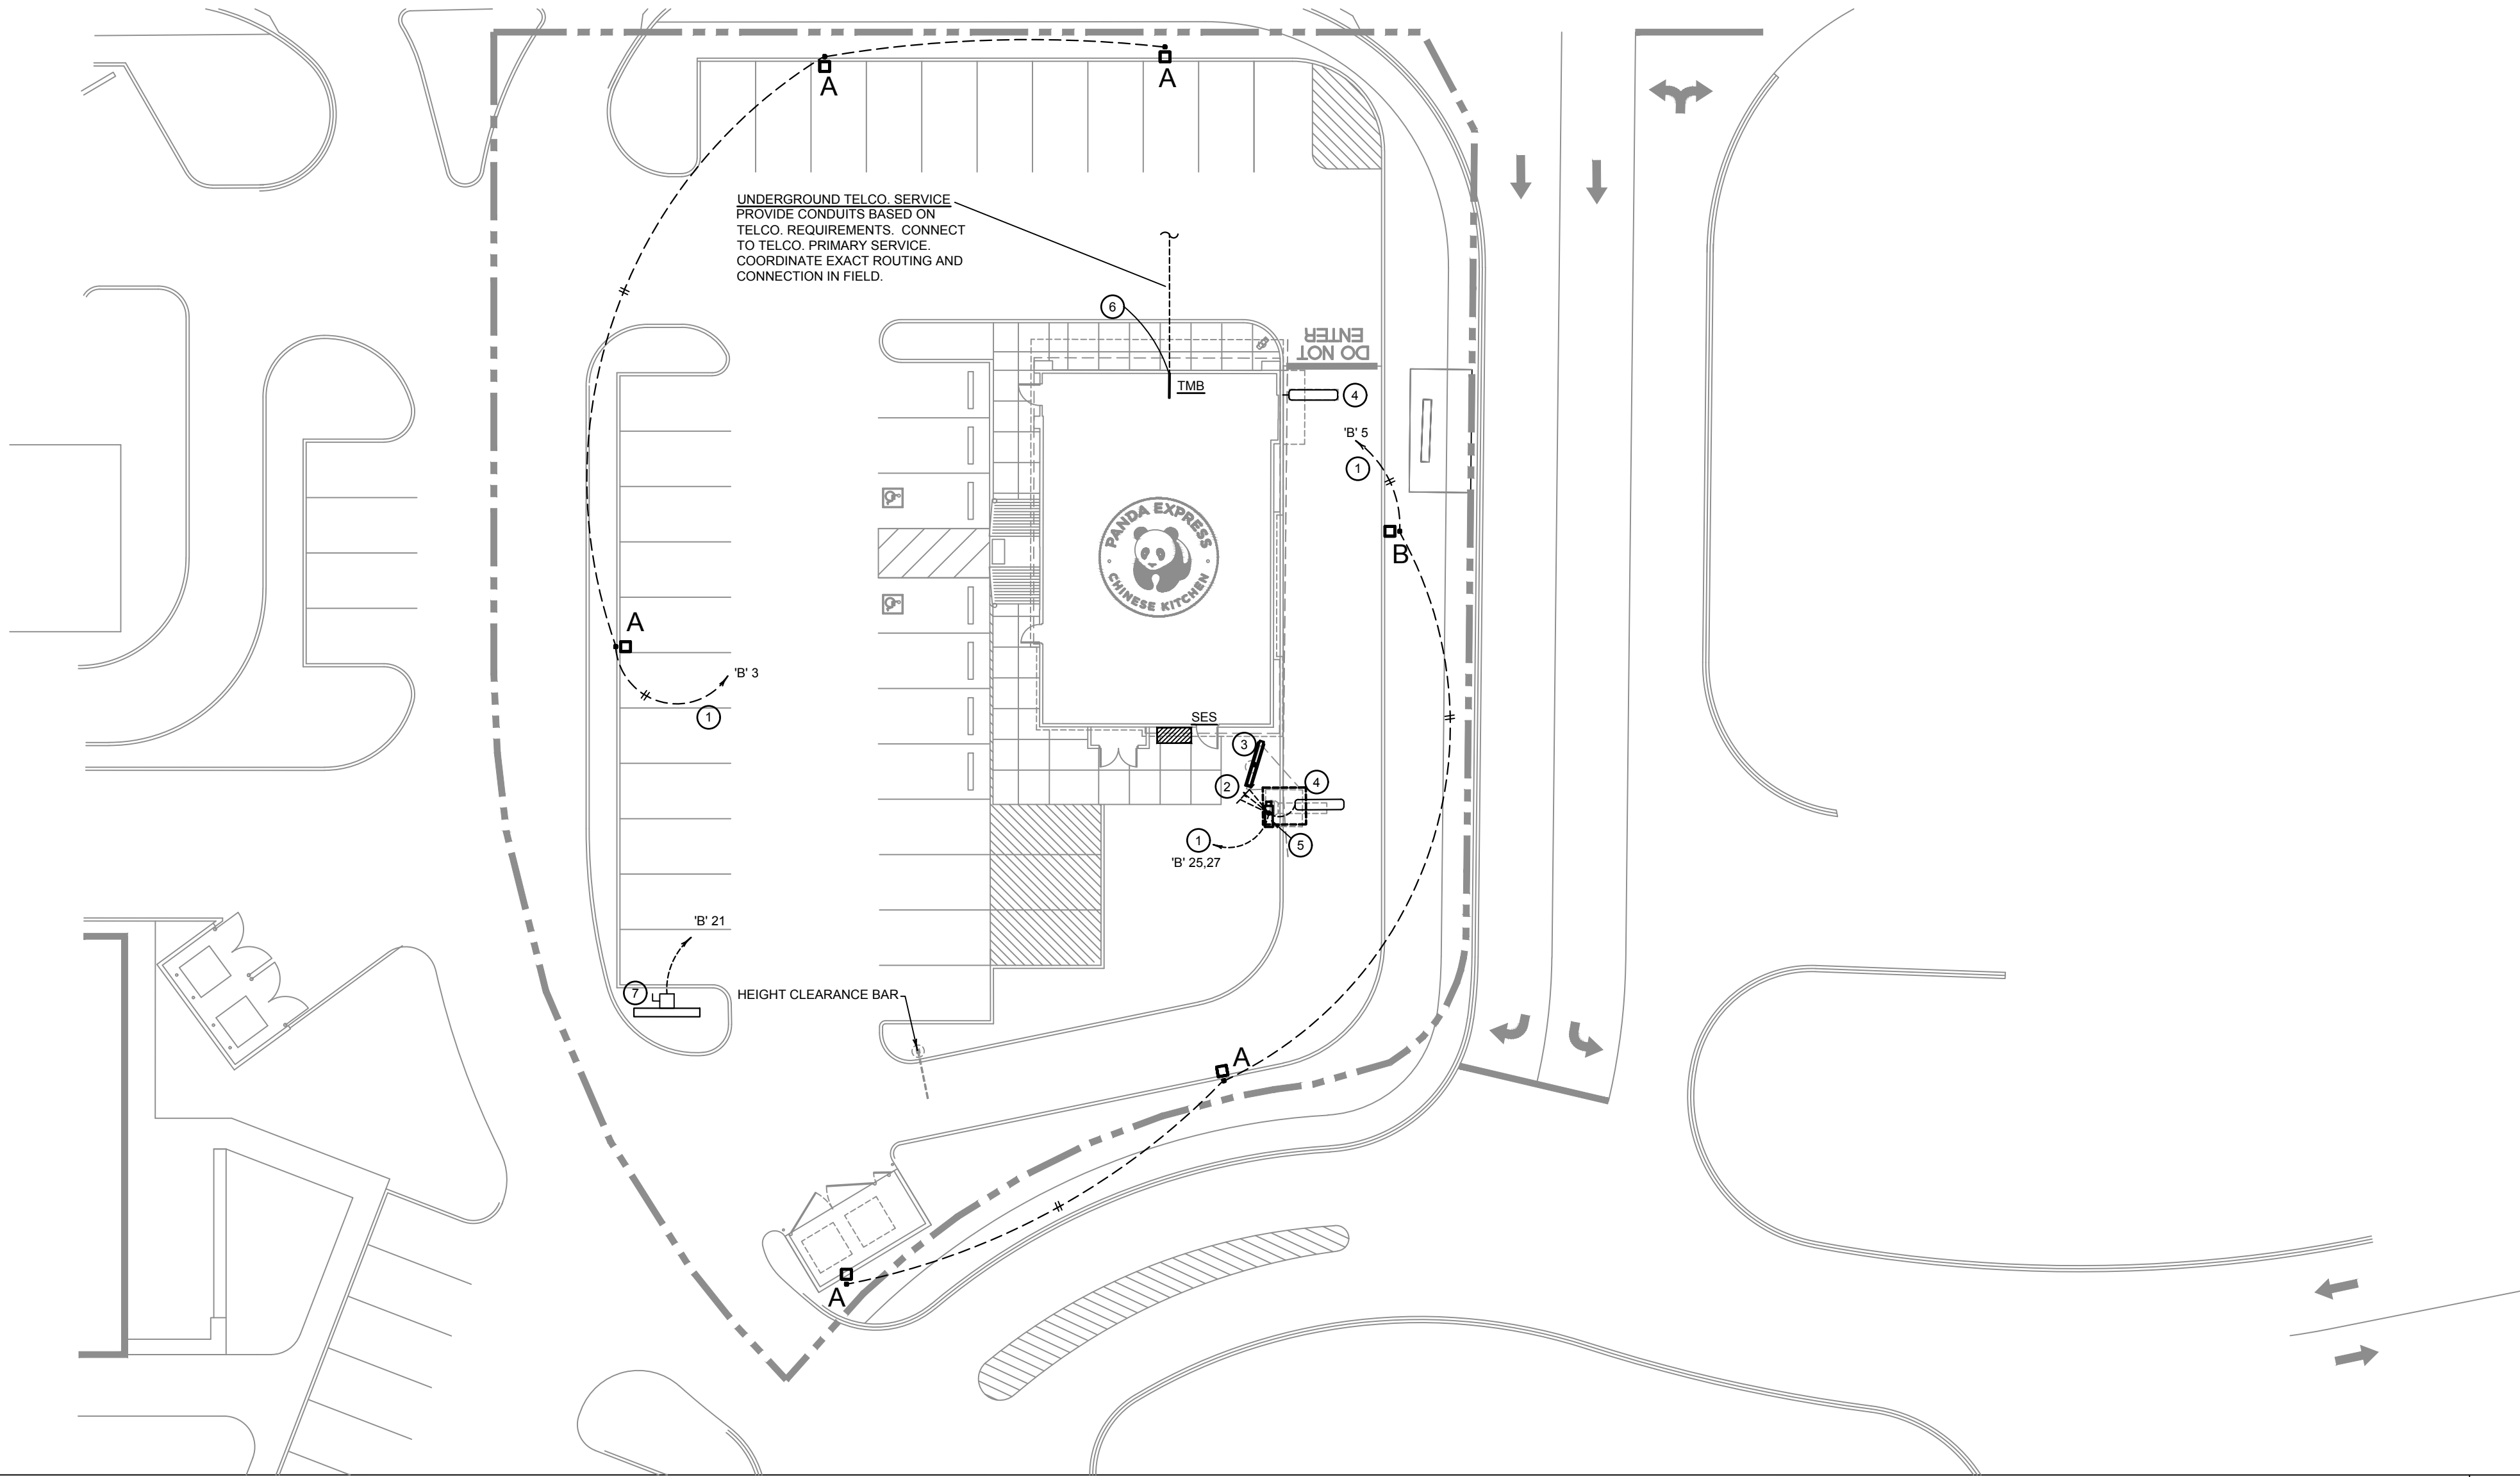

SITE & EXTERIOR LIGHTING PLAN

1

1" = 20'-0"

E-105



PANDA EXPRESS INC.
1683 Walnut Grove Ave.
Rosemead, California
91770
Telephone: 626.799.9898
Facsimile: 626.372.8288

All ideas, designs, arrangement and plans indicated or represented by this drawing are the property of Panda Express Inc. and were created for use on this specific project. None of these ideas, designs, arrangements or plans may be used by or disclosed to any person, firm, or corporation without the written permission of Panda Express Inc.


REVISIONS:

ISSUE DATE:

1ST	PERMIT SET	10-05-18
2ND	BID SET	11-20-18

DRAWN BY: BEN

PANDA PROJECT #: S8-19-D6462
ARCH PROJECT #: 180044.013

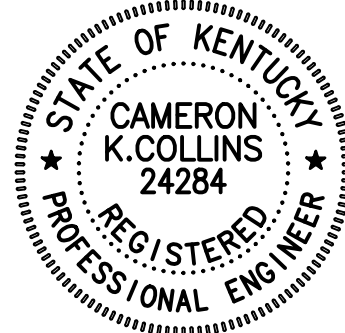

PANDA EXPRESS

TRUE WARM & WELCOME 2200
CONESTOGA PKWY & HISTORICAL TRAIL
SHEPHERDSVILLE, KY 40165

E-105

SITE & EXTERIOR LIGHTING PLAN